
 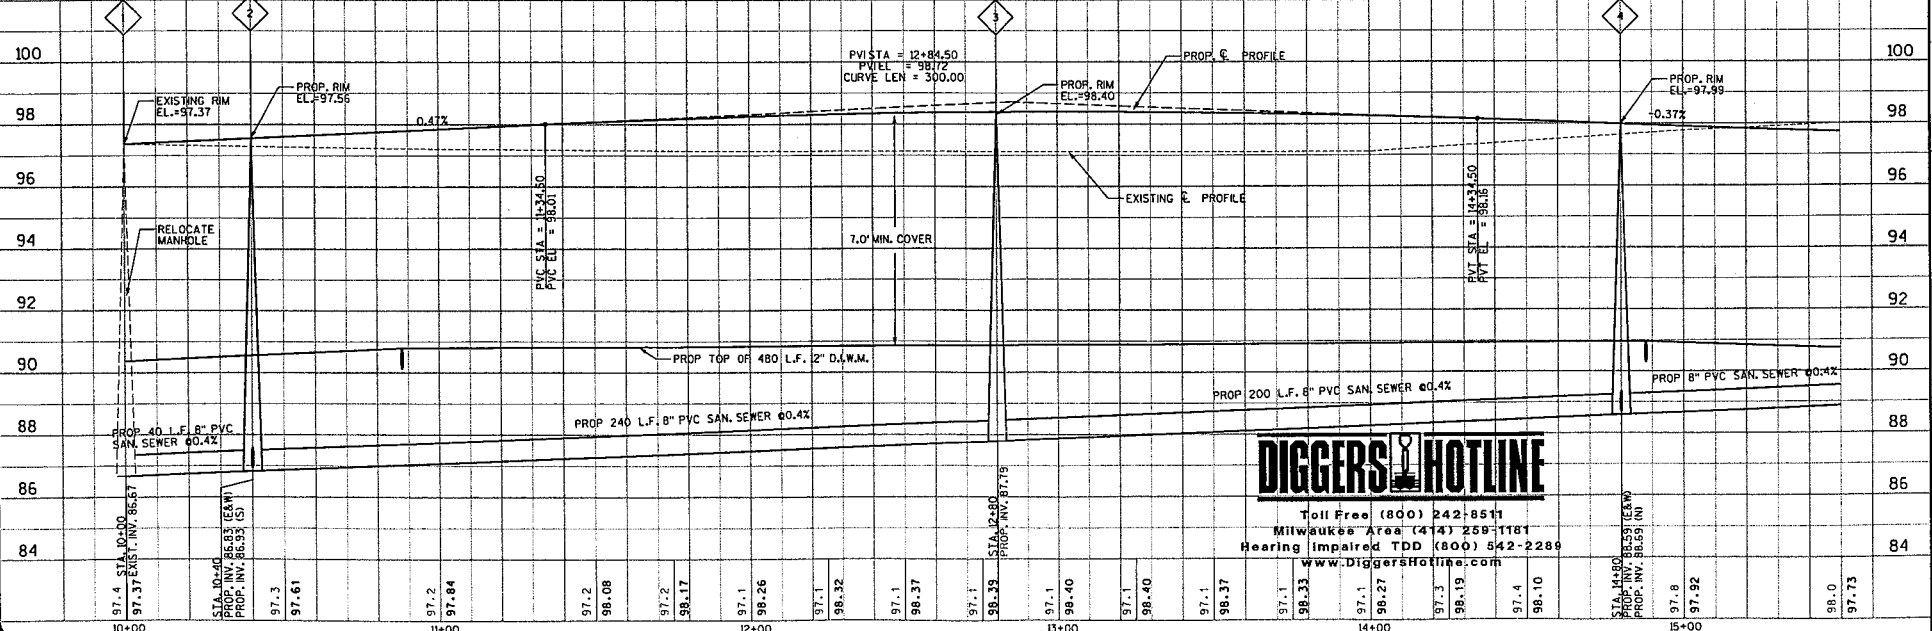



BM. NO.	STATION	DESCRIPTION	ELEV.
1	9+85	HYDRANT	100.00

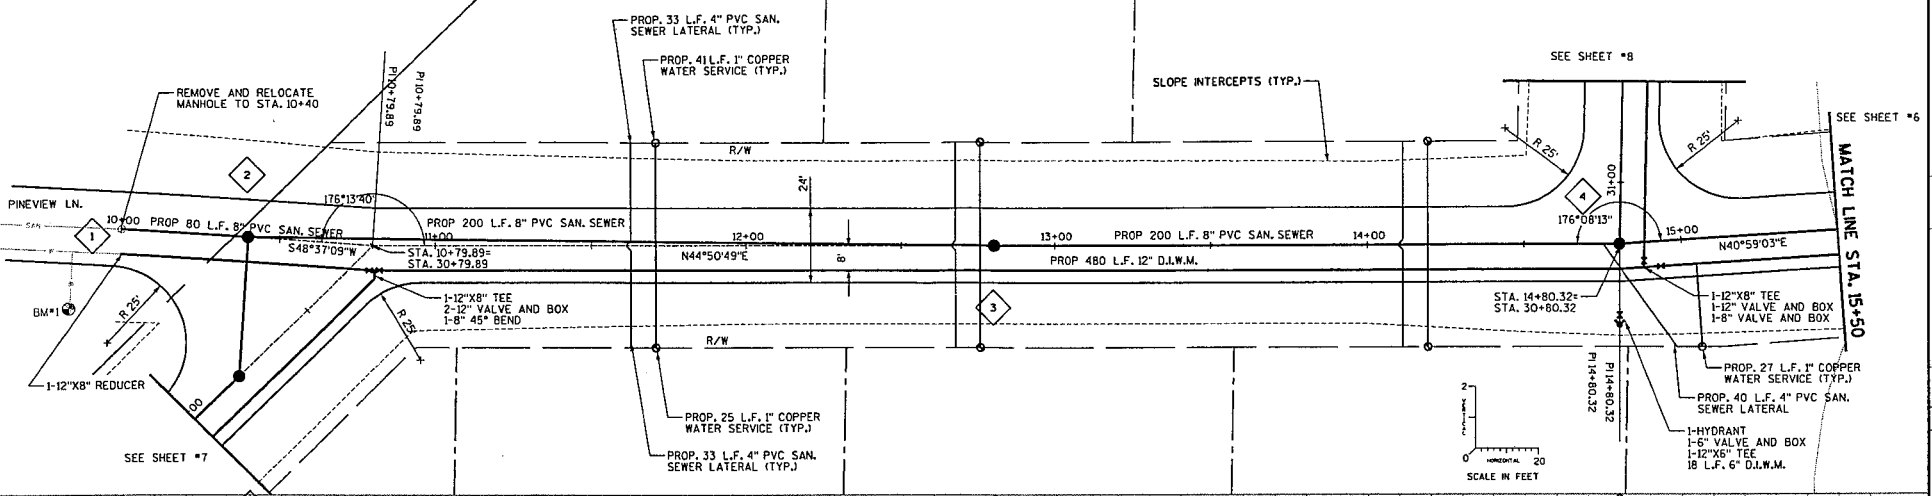

**DIGGERS HOTLINE**

Toll Free (800) 242-8511  
 Milwaukee Area (414) 259-1181  
 Hearing Impaired TDD (800) 542-2289  
[www.DiggersHotline.com](http://www.DiggersHotline.com)

TRANSPORTATION • MUNICIPAL DEVELOPMENT • INDUSTRIAL

100 N. Second St., Milwaukee, WI 53201  
 414-224-1000 FAX: 414-224-1015  
 © All rights reserved.

**MSA**  
 ENGINEERING SERVICES

PROJECT NO. 380373	DATE	SCALE AS SHOWN
TITLE	DATE	SCALE AS SHOWN
DESIGNED BY: SM	CHECKED BY: SM	DATE: JUNE 2002

PLAN AND PROFILE  
 PEEHL SUBDIVISION  
 UTILITIES  
 TOMAHA WISCONSIN

980373  
 5 4 97.73